

DRAINAGE

Foul water sanitary plumbing and drainage shall comply with NZBC G13/AS1 and AS2.

Stormwater drainage shall comply with NZBC E1/AS1

Size of all drains to comply with the above standards. Lay all drains to required falls.

Stormwater to discharge existing stormwater tank.

Foul water to be disposed of to existing septic tank and effluent field.

Final location of waste pipes may vary to what is shown on these plans. It is the responsibility of the drain layer to provide the builder on completion a producer statement and as laid drainage plan.

WASTE PIPES

	SIZE	FALL
Toilet	100mmØ	1:60
Kitchen	65mmØ	1:40
Vanity	40mmØ	1:40
BATH	40mmØ	1:40
Hand basin	40mmØ	1:40
Tiled shower	50mmØ	1:40
Acrylic shr	40mmØ	1:40

DRAINAGE KEY


TERMINAL VENT	TV
GULLY TRAP	GT
INSPECTION JUNCTION	IJ
INSPECTION BEND	IB
BACK VENT	BV
DOWN PIPE	DP
100mmØ SEWER DRAIN	
STORM WATER DRAIN	

DRAINAGE PLAN

SCALE 1:100

MASTER PLAN
8-09-09

WAIKATO DISTRICT COUNCIL
17 SEP 2009
Time..... Initials.....
NGARUAWAHIA

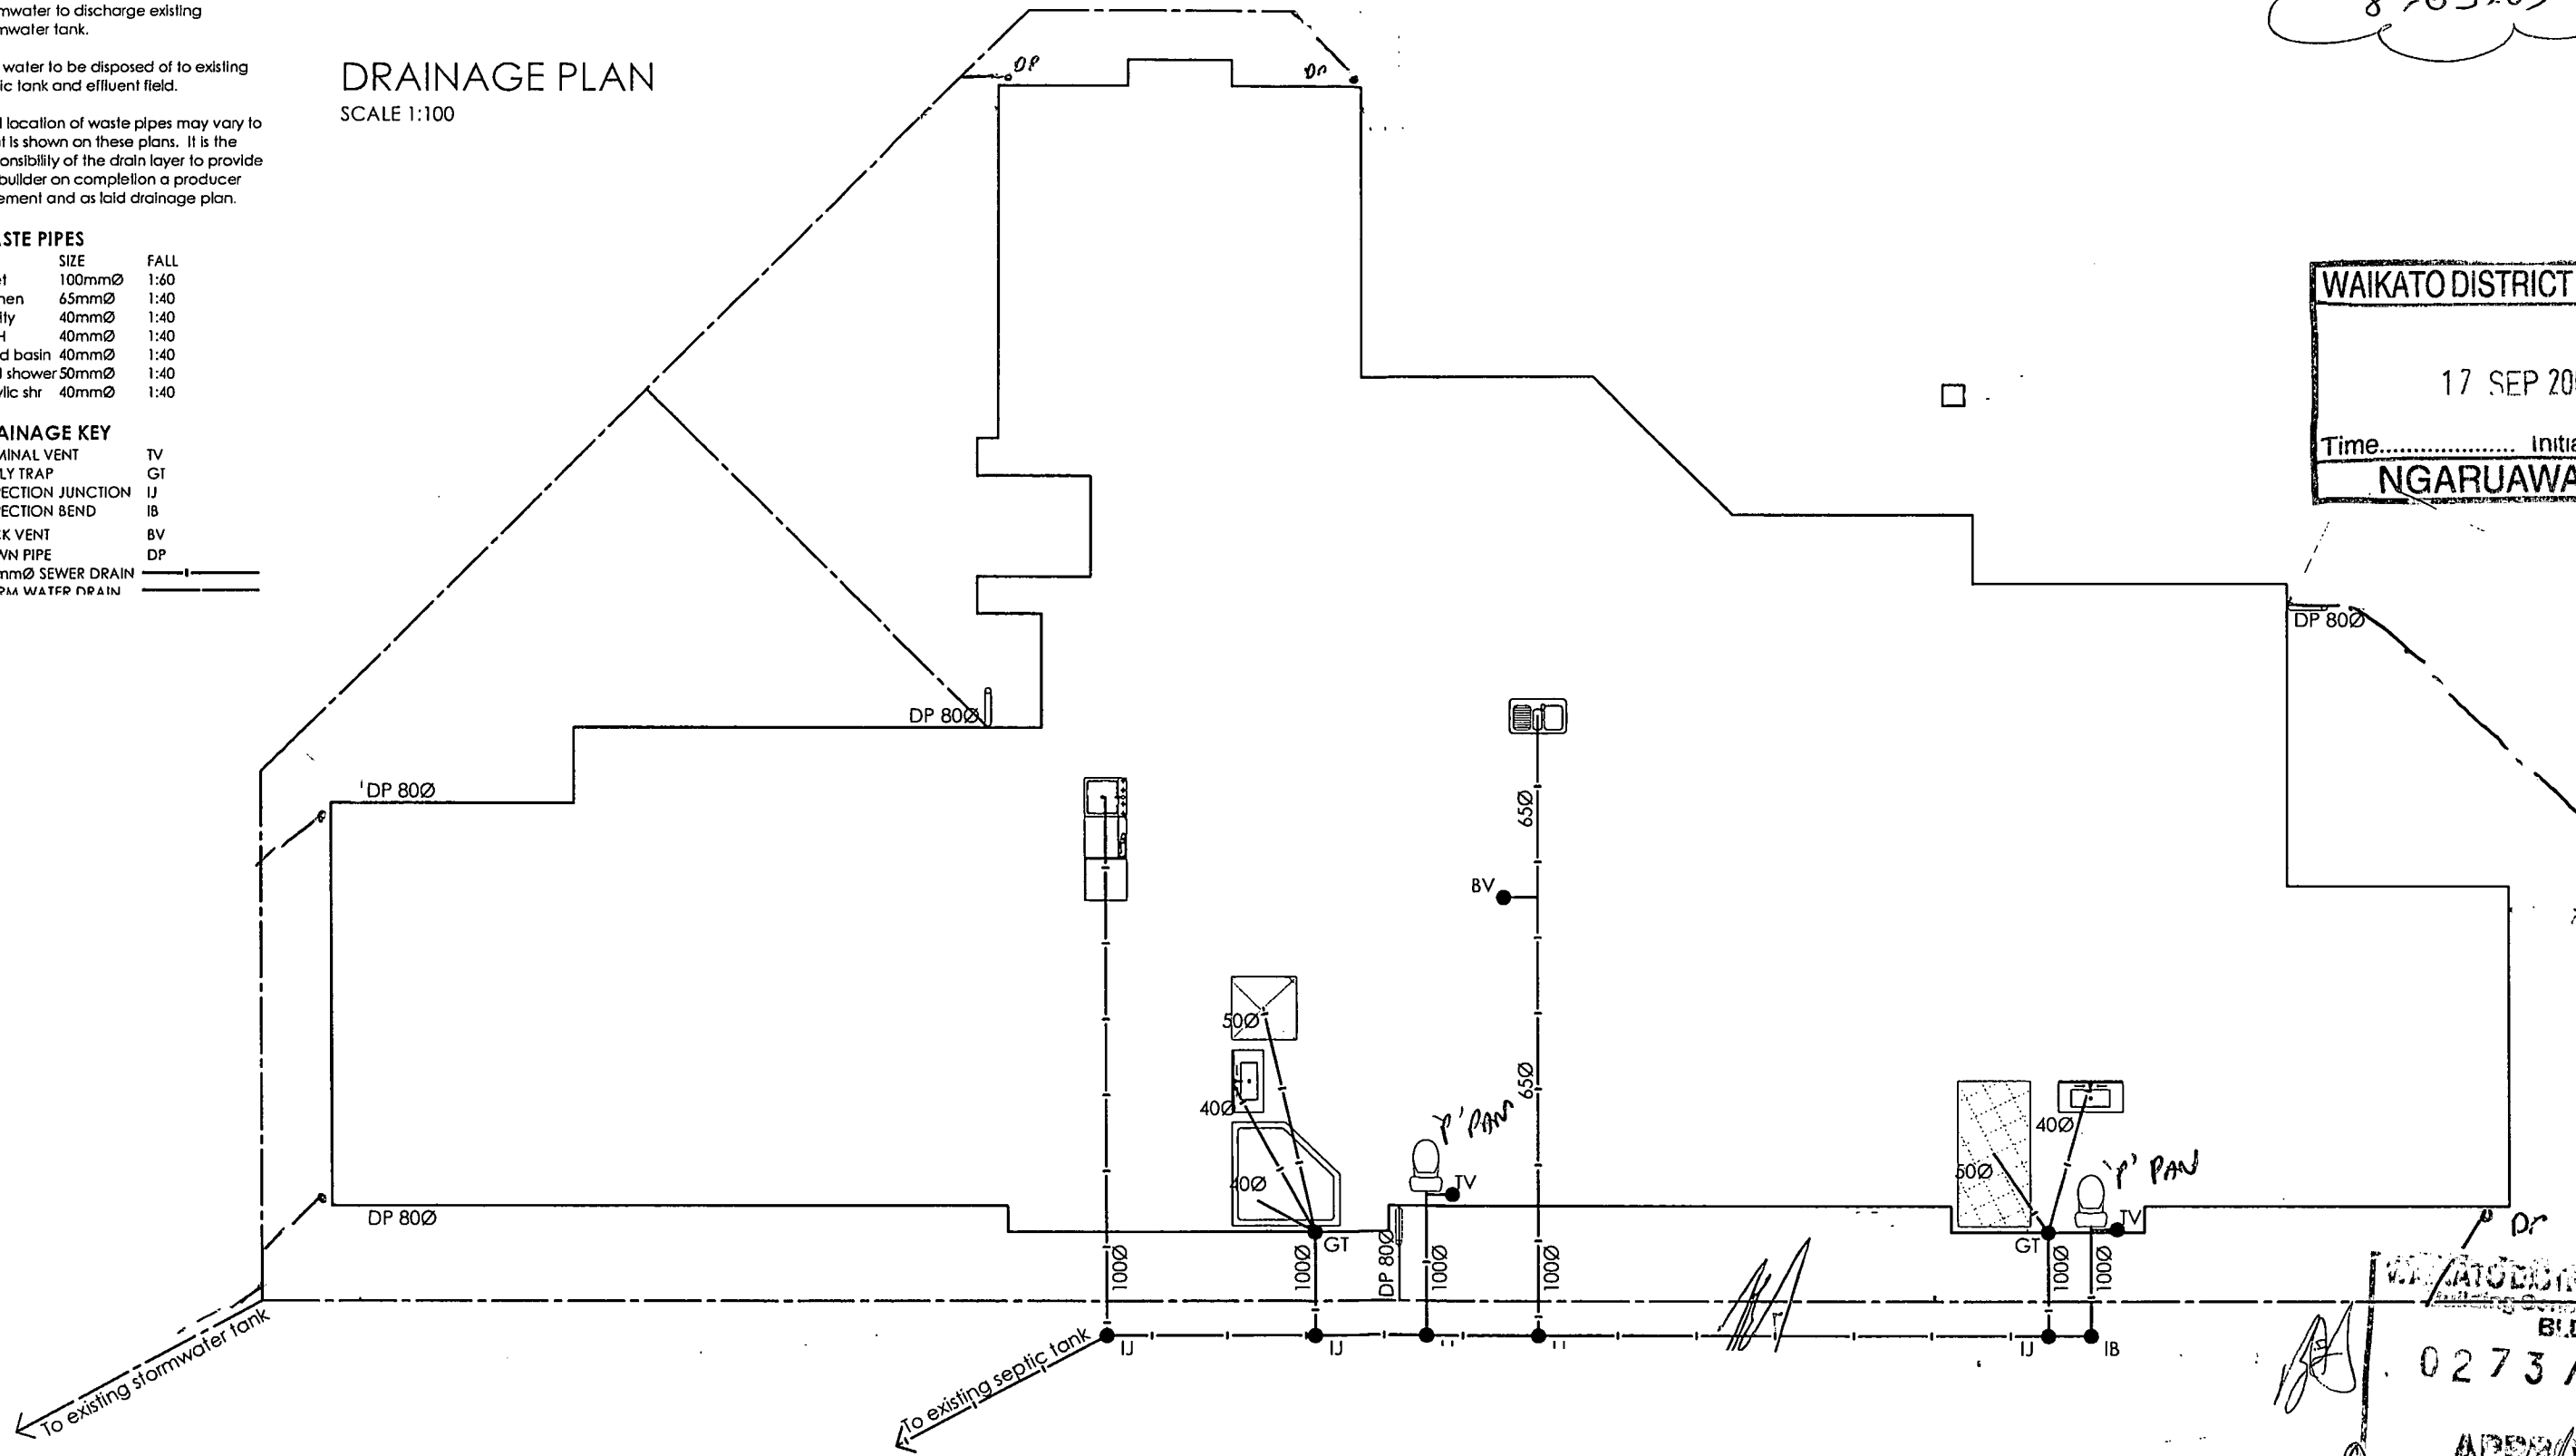

WAIKATO DISTRICT COUNCIL
Building Consent Number
B.C.D
0273/10
APPROVED
BTA



PLANS TO BE READ IN CONJUNCTION WITH SPECIFICATIONS

©The copyright of this drawing remains the property of Jennian Homes Waikato LTD, any unauthorized use will result with appropriate legal action©

Client
L & B SMITH
115 Kiroa Road
PUKETAHA
Lot 1, DPS 377262

Drawing Title
Drainage Plan

Designer
Marquerite McMillan

Date
25/08/2009, 5:32 p.m.

Sheet #
02/20