
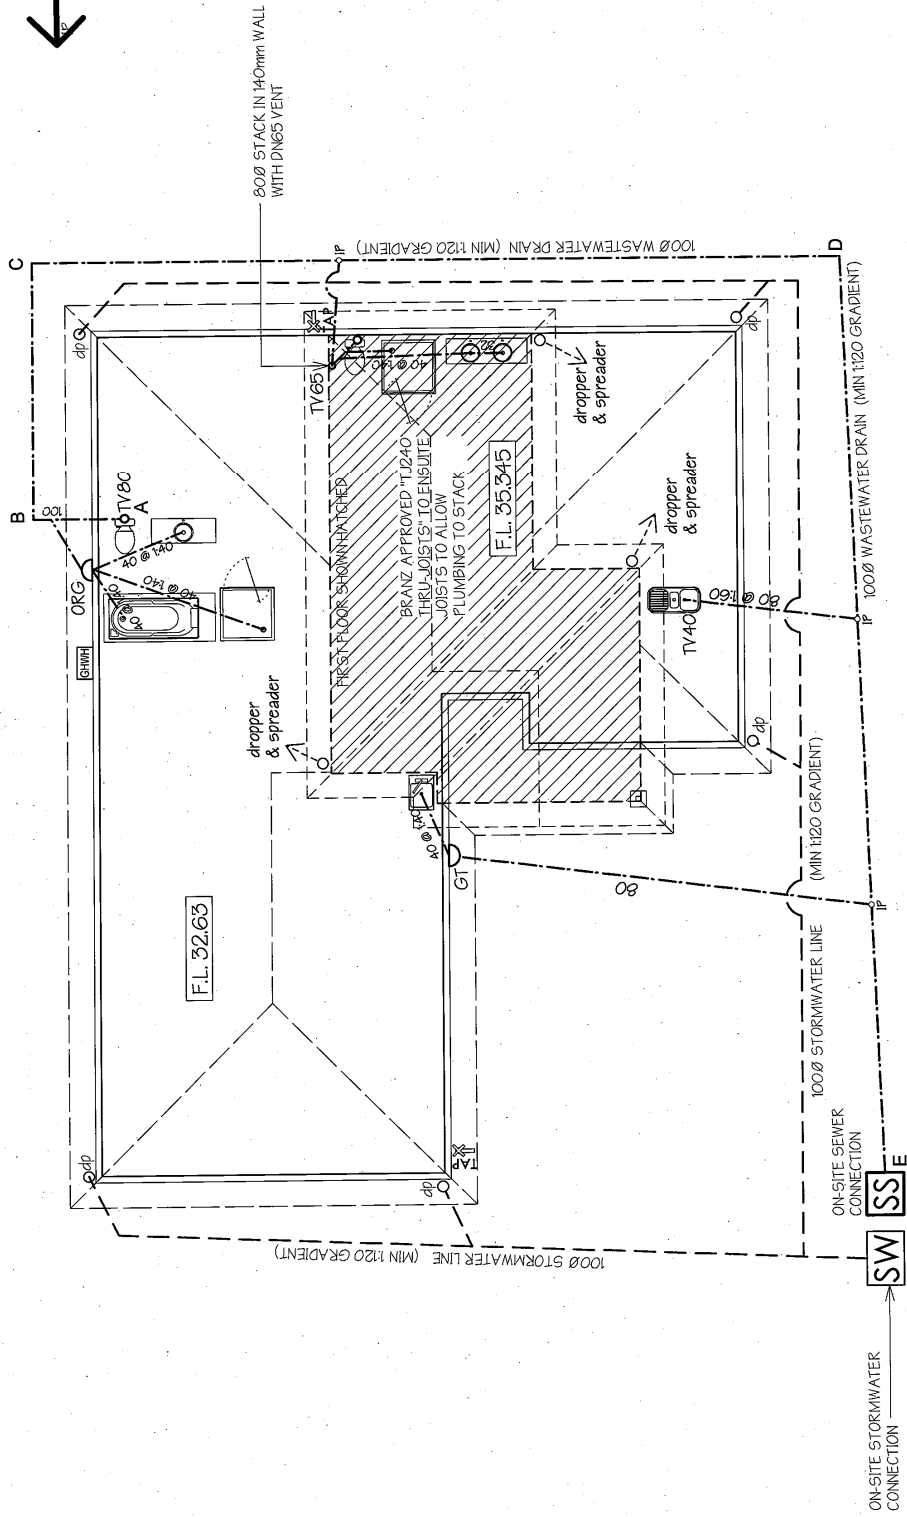


PLUMBING SCHEMATIC
SCALE N.T.S.

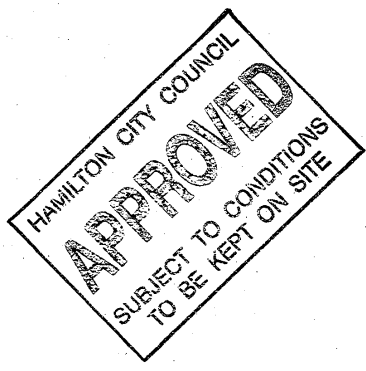

PLUMBING AND DRAINAGE PLAN
SCALE 1:100
READ IN CONJUNCTION WITH SEWER LONGITUDINAL SECTION ON SITE PLAN SHEET

DRAINAGE NOTES

1. DRAINAGE IS *DIAGRAMATIC ONLY*. ALL DRAINAGE IS TO COMPLY WITH NES/ASS5500 & NZBC REQUIREMENTS
2. PIPE SIZES NOTED ARE MINIMUM DNs ONLY.
3. ALL CONNECTIONS TO BE LOCATED ON SITE PRIOR TO COMMENCEMENT, AND INVERTS CHECKED.

DOWNEY designerHOMES	
job:	RENWICK RESIDENCE DURHAM HEIGHTS HAMILTON
sheet:	DRAINAGE PLAN
© COPYRIGHT 2009	drawn: KTJ
plan: LOFTUS	date: MAY 2009
scale on A3	1 : 100
	sheet no: 2

ADDRESS: Durham Hts 16
LEGAL DESC: LOT 51 DP 368150
CONSENT No.: 2009/22419
DESCRIPTION: New 2 Storey
Dwelling with Attached Garage